

STATEMENT OF PASSING OVER INFORMATION

This information has been supplied by the vendor or the vendor's agents. Accordingly, Ownly (REAA 2008) and Sold On Kapiti Limited is merely passing over the information as supplied to us by the vendor or the vendor's agents.

We cannot guarantee its accuracy and reliability as we have not checked, audited, or reviewed the information and all the intending purchasers are advised to conduct their own due diligence investigation into the same.

To the maximum extent permitted by law Ownly (REAA 2008) and Sold On Kapiti Limited does not accept any responsibility to any person for the accuracy of the information herein.



SOLD ON KĀPITI
REAL ESTATE

58A Kotare Street Specifications & Allowances:

Garage/Laundry

- Garage carpet
- Slimline super tub
- Colorsteel garage door up to Nevada in styles with automatic opener (Windsor Grey)

Master Bedroom

- Carpet Belgotex park View garden
- Ducted heat pump

Ensuite

- Full wet room, tiled floor to ceiling (including shower)
- Tiles on floor
- 1x niche in the shower
- 1 x LED mirror above vanity
- 1x vanity Newtech Brookfield Slim Wall Hung Vanity 900mm vintage ash
- 1 x Vanity tap Adesso Mila
- 1x toilet Adesso Urban 2 back to wall rimless
- 1x slide rail
- 1x shower mixer Adesso Mila
- Underfloor heating
- 1x heated towel rail Quadro 7 Bar 450mm
- 1x toilet roll holder
- 1x 1200mm x 900mm shower with frameless glass and sliding doors

Master Wardrobe

- Carpet Belgotex park View garden
- Wardrobe shelving

Hallway

- Carpet Belgotex park View garden

Bed 2

- Floor grill for ducted heat pump
- Wardrobe
- 1x Melamine shelf with 1x hanging rail in wardrobe
- Carpet Belgotex park View garden
-

Bed 3

- Carpet Belgotex park View garden
- Floor grill for ducted heat pump
- Wardrobe
- 1x Melamine shelf with 1x hanging rail in wardrobe

W/C

- Floor tiles with 100mm tile skirting
- 1x toilet Adesso Urban 2 back to wall rimless
- 1x wall hung hand basin Brookfield junior wall hung vanity
- 1 x Vanity tap Adesso Mila
- 1x toilet roll holder

Hallway storage cupboard and storage cupboard next to office

- Carpet Belgotex park View garden
- 4x levels of 100mm x 20mm clear pine timber slatted shelves (unpainted)

Bathroom

- Full wet room, tiled floor to ceiling (including shower)
- Tiles on floor
- 1x LED mirror above vanity
- 1x niche in the shower
- 1x vanity Newtech Brookfield Slim Wall Hung Vanity 1200mm vintage ash
- 1 x Vanity tap Adesso Mila
- 1x slide rail
- 1x shower mixer Adesso Mila
- Underfloor heating
- 1x heated towel rail Quadro 9 Bar 600mm
- 1x toilet roll holder
- 1x 1200mm x 900mm shower with frameless glass and sliding doors
- 1x free standing bath Athena Contro back to wall
- 1x bath spout Adesso Mila
- 1x bath mixer

Kitchen/Dining/Living

- Floating hard floor in kitchen & dining Pergo
- Carpet in living
- 1x induction hob
- 1x wall oven
- 1x dishwasher
- 1x waste master
- Custom kitchen as per plan attached
- Stone bench tops

- Undermount sink, 1 full and a half bowl
- 1x sink tap
- Floor grills for ducted heat pump in this area
- 1x Heat pump control panel

Entry

- Hard floor Pergo first 1500mm in the front entrance
- Colorsteel Parkwood door 3HV with 600mm pull handle
- 1x Yale touchscreen dead bolt

Western deck

- 90mmx20mm Kwila decking
- Frameless glass balustrade (as per plan)

Front deck

- 90mmx20mm Kwila decking
-

Exterior

- Colorsteel spouting (Winsor Grey)
- PVC downpipes
- Cladding CP839 horizontal cedar & BGC Stratum Standard and Duo as per elevation
- 1x 10,000L water tank with pump
- All areas outside to be top soiled and grassed
- 1x letterbox with numbers
- Fascia timber
- QD5 Long run iron (Windsor Grey)
- 3 x hose tapes
- Driveway concrete trowel finish

Painting

- 1x wall colour
- 1 x ceiling colour
- 1 x door colour
- 1 x woodwork colour
- 1x colours for the outside has been allowed for
- Cedar Dryden Platinum

Windows

- Powder coated aluminium (Windsor Grey)
- Clear thermally broken glass
- Obscure etchilte bathrooms and WC

Internal

- 1 x 250L Hot water cylinder
- Door style HAG4
- Smoke alarms
- Square stop
- 60mm single bevel skirtings and architraves
- Ducted heat pump

Insurances

- Certified builders 10 year Halo Guarantee

Electrical

- As per electrical plan



KITCHEN
CREATORS

Kitchen Design
& Manufacturing







Designer
Nicola
08/08/25

Paraparaumu
144 Kapiti Road
P: 04 2982421
F: 04 2982408

info@kitchencreators.co.nz

www.kitchencreators.co.nz


Not drawn to scale.
All sizes are subject to
final site visit.

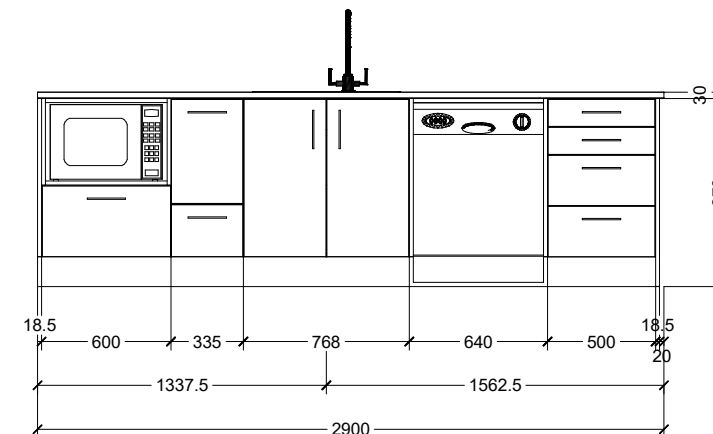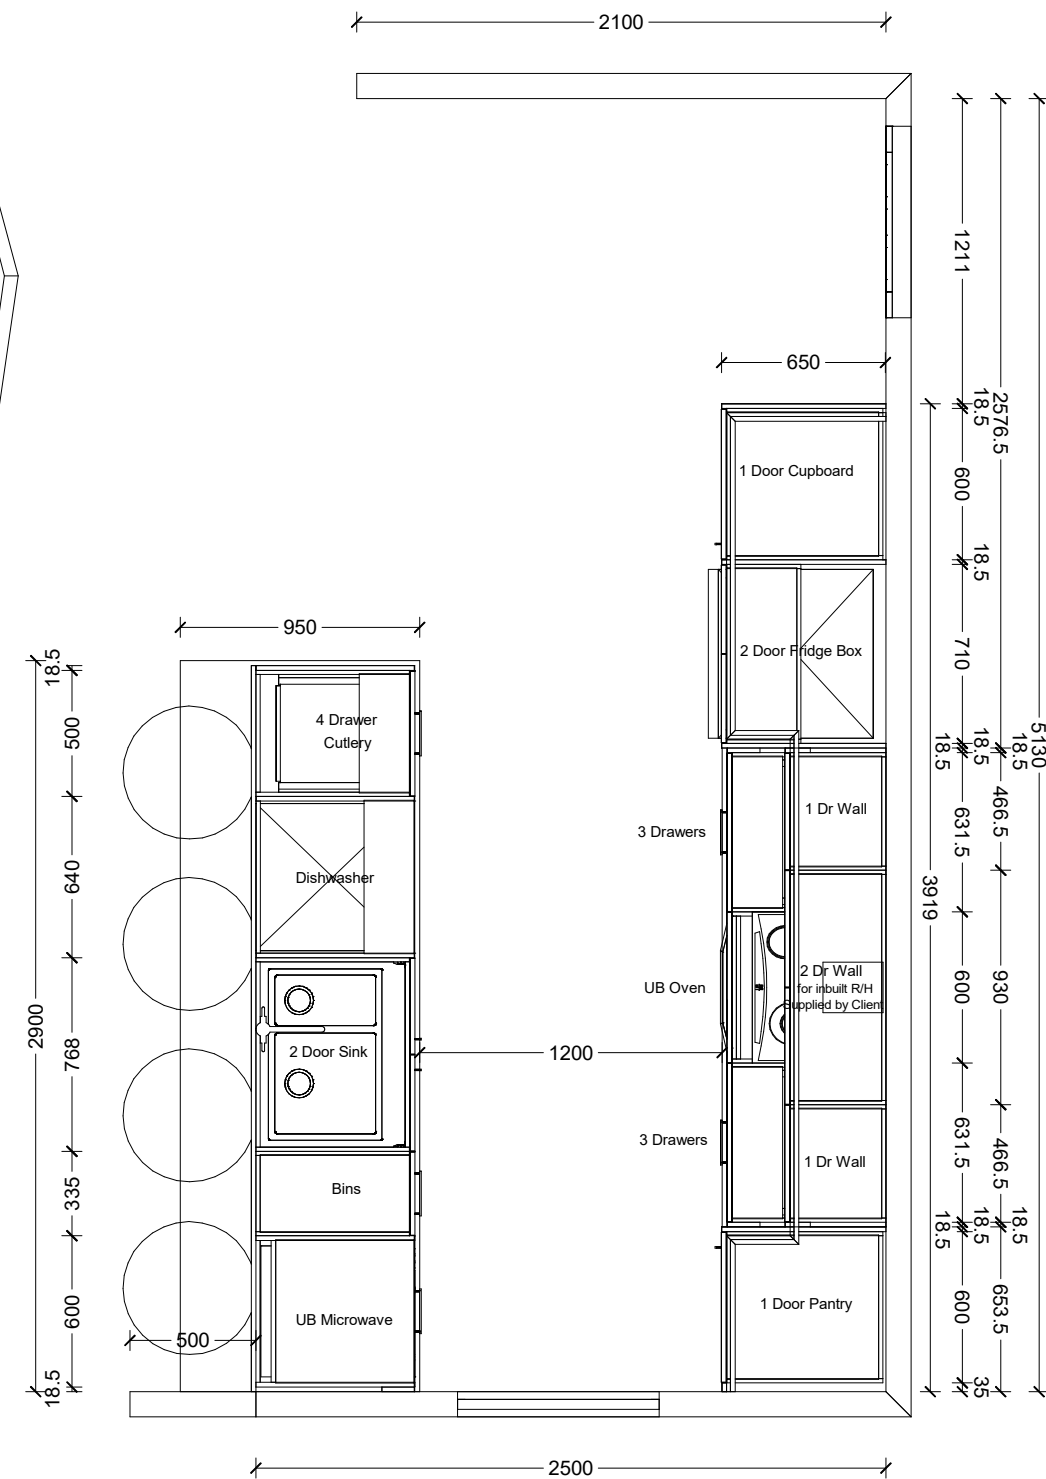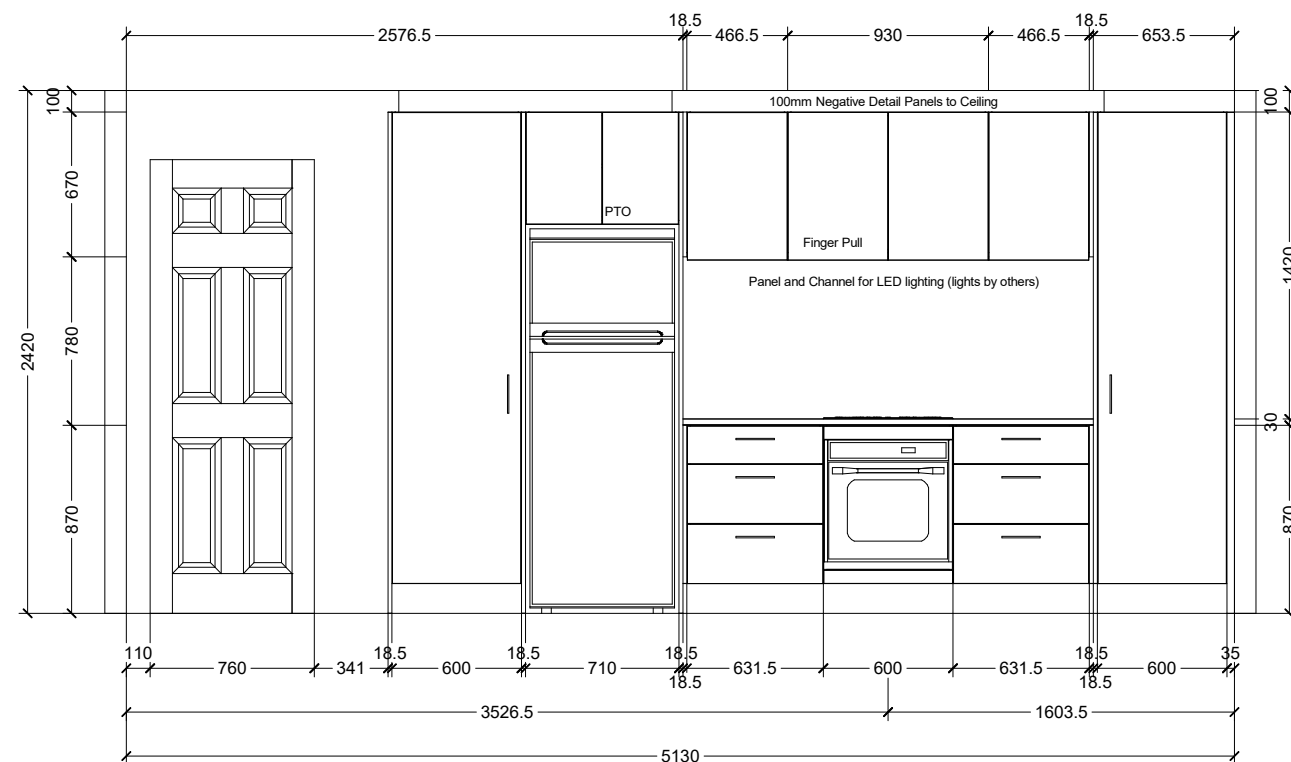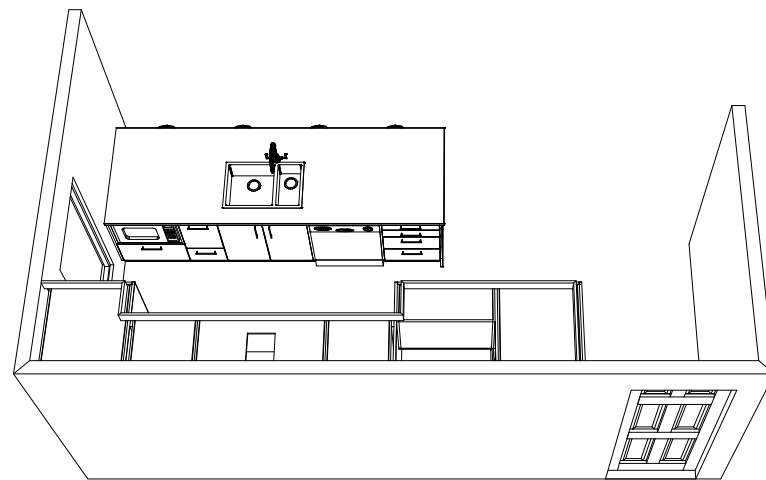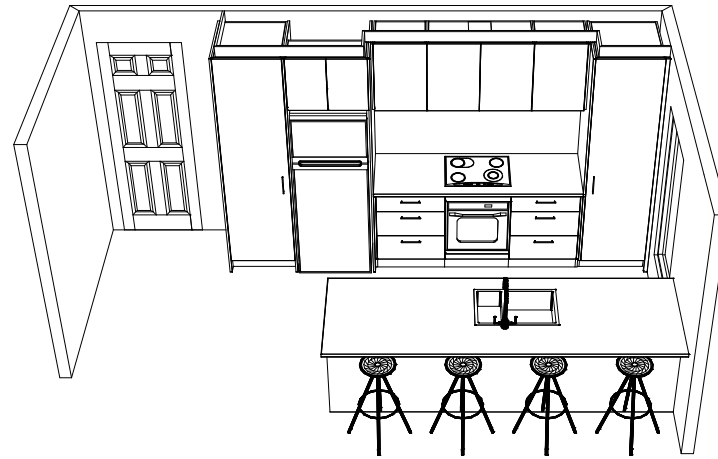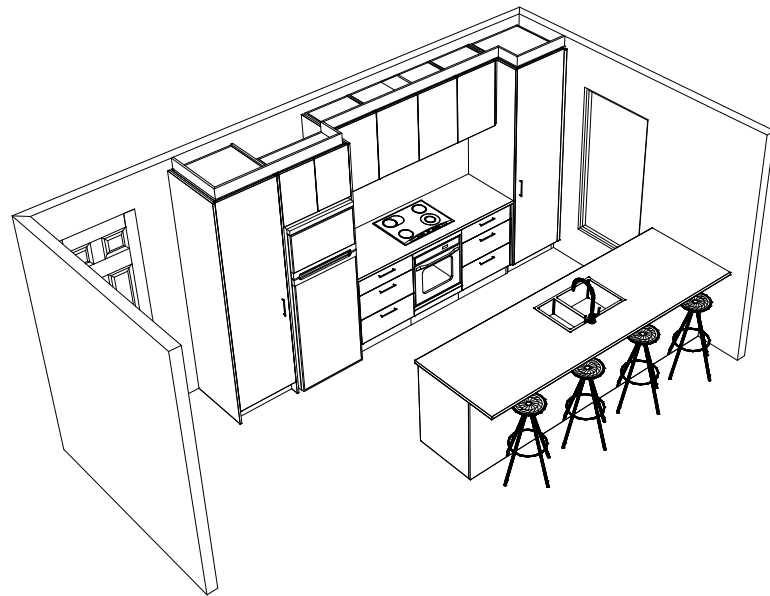


The plans are Copyright and remain the property of Kitchen Creators Ltd. All colours and textures in 3D renders are representative only and may not be accurate.

Name: C&D Trust

Job: Anderson Construction - 58A Kotare Street

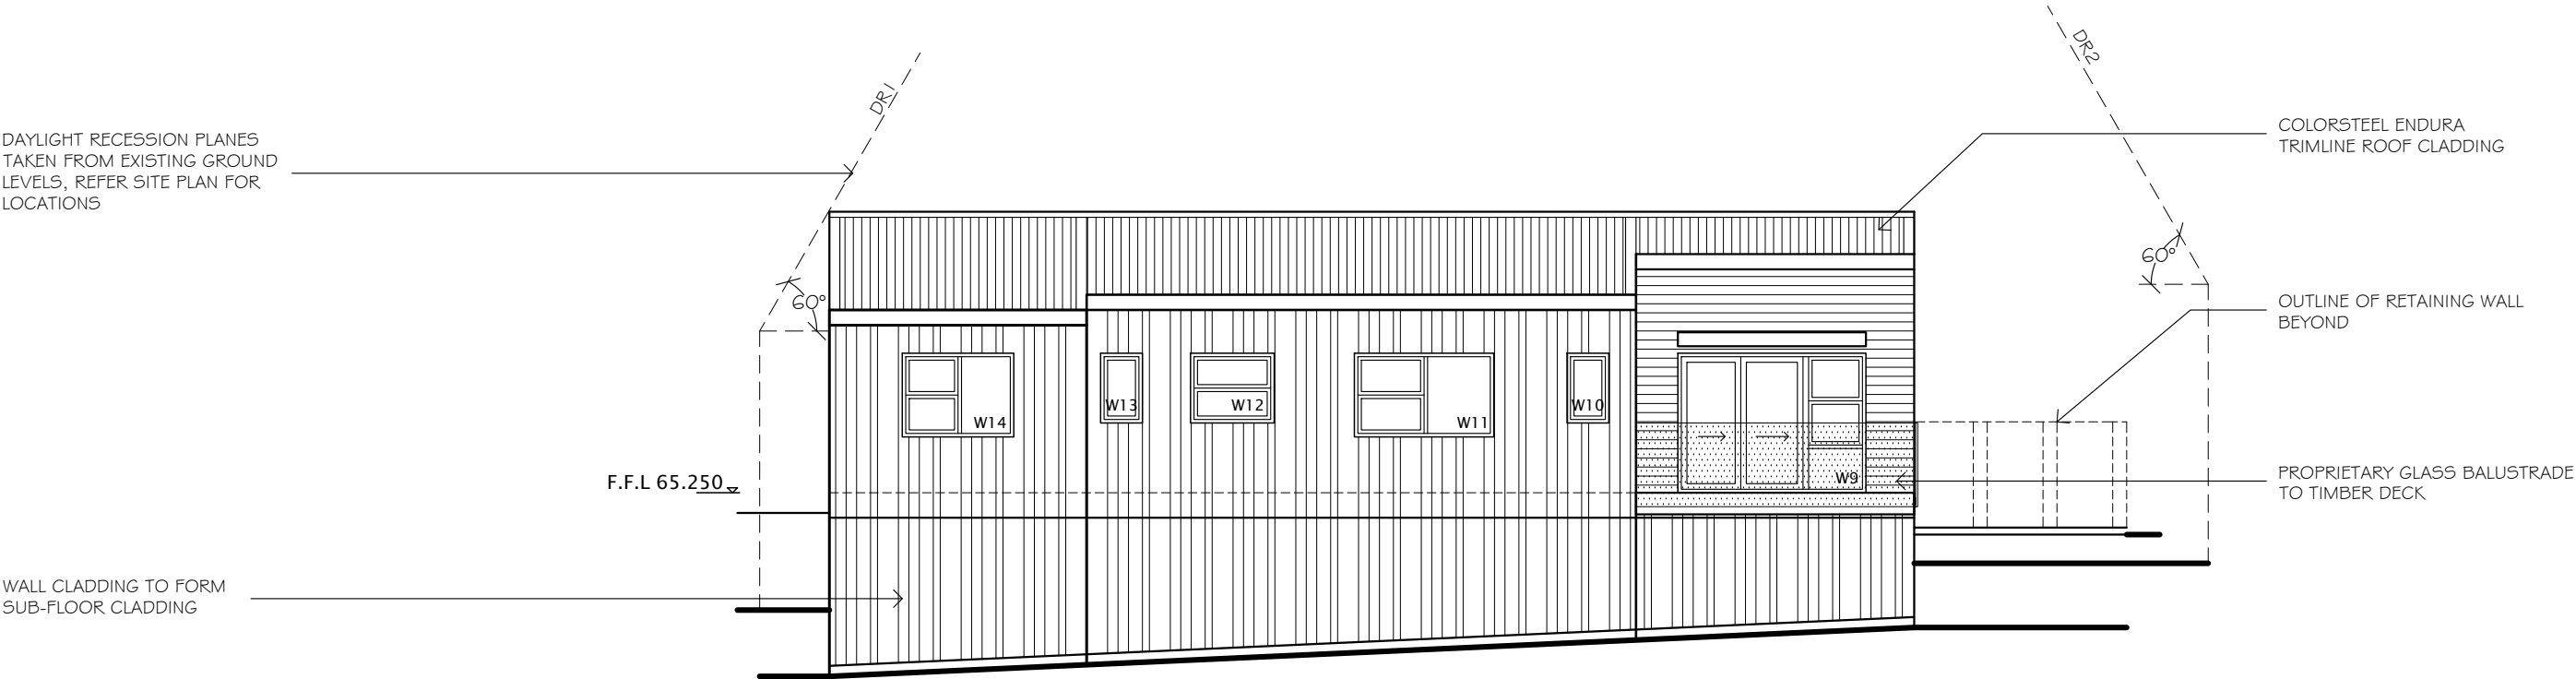

ELEVATION 3
SCALE 1:100

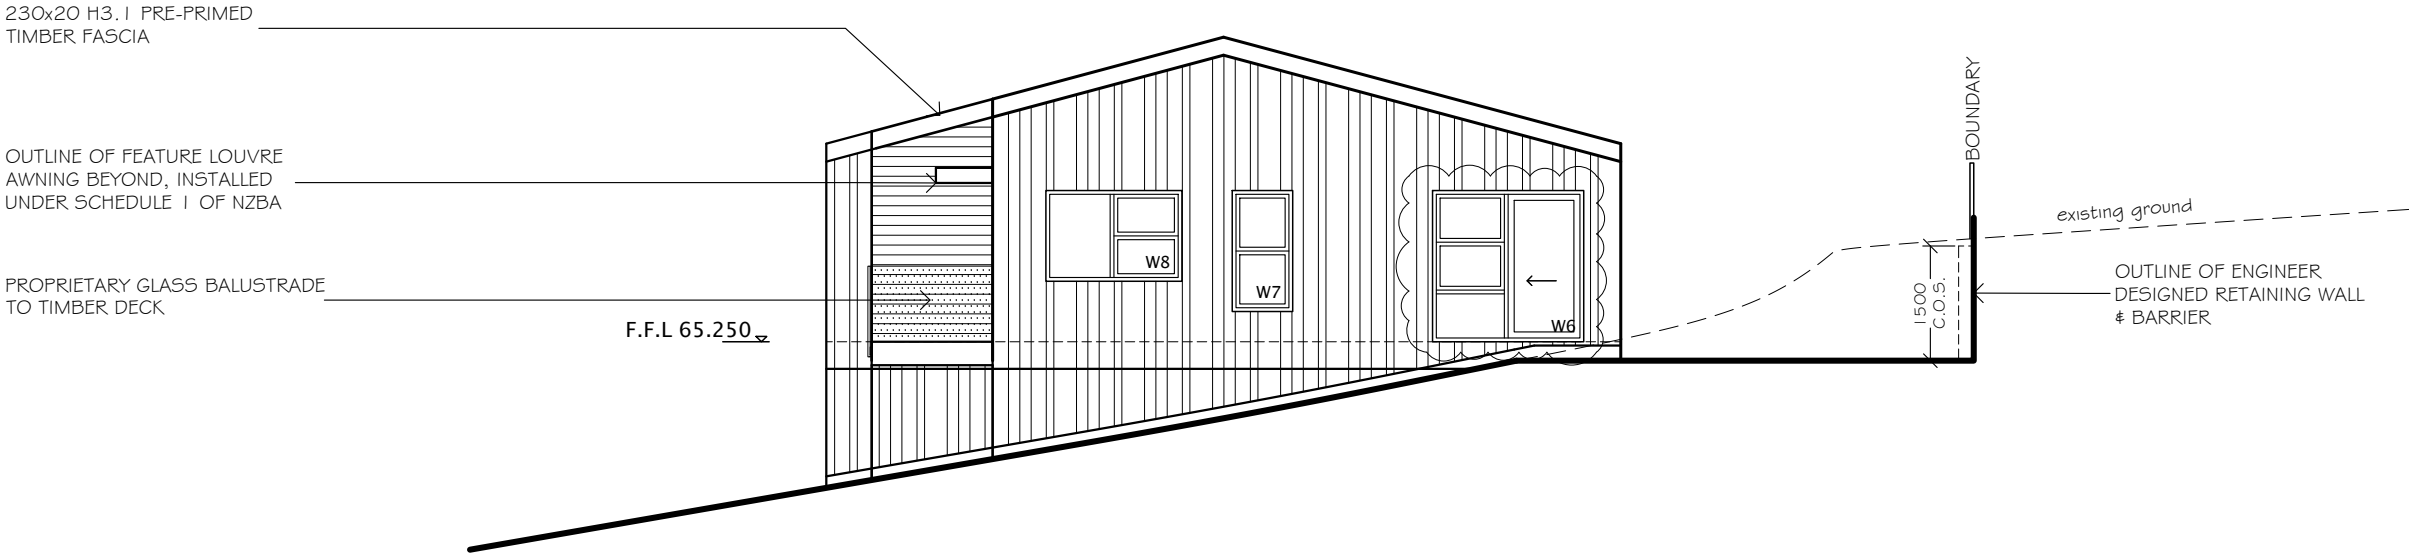

ELEVATION 4
SCALE 1:100
LEGEND:


- NOMINATED BGC STRATUM RANDOM PATTERN CAVITY CLADDING
- SELECTED DOUBLE SPLAY CUT RUSTICATED WEATHERBOARDS
- NOMINATED COLORSTEEL TRIMLINE ROOFING

ELEVATION NOTES:

- ALL VERTICAL STRATUM CLADDING FIXED OVER BGC HORIZONTAL CAVITY BATTENS INSTALLED TO MANUFACTURERS SPECIFICATIONS
- ALL HORIZONTAL WEATHERBOARD CLADDING FIXED OVER NOMINATED CAVITY BATTENS
- ALL CLADDING SYSTEMS FIXED OVER WATERGATE PLUS BUILDING WRAP, CAVITY BASE CLOSURES TO ALL AREAS
- REFER SHEETS 18-25 & SPECIFICATION FOR CLADDING DETAILS
- ALL CLADDING INSTALLED STRICTLY TO MANUFACTURERS SPECIFICATIONS IN PARTICULAR FIXINGS, GROUND CLEARANCES & FLASHINGS
- INSTALL BLOCKING/STUDS AS REQUIRED FOR CLADDING SETTING OUT


STRATUM PATTERN NOTES:

VERTICAL BGC STRATUM, STRATUM DUO & STRATUM OFFSET CAVITY FIXED CLADDING OVER BGC HORIZONTAL CAVITY BATTEN SYSTEM, REFER DETAIL BELOW FOR CLADDING SETTING OUT

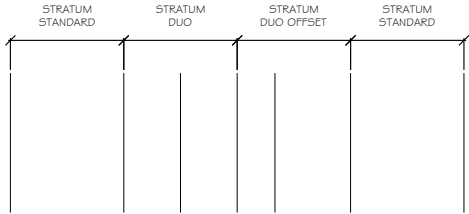

STRATUM RANDOM PATTERN LAYOUT
SCALE 1:20

 DRAFTED ARCHITECTURAL DESIGN	11 TE HARAWIRA STREET OTAKI,NZ PHONE: 022 607 0234 EMAIL: drafted.nz@gmail.com www.drafted.nz		NOTES -DO NOT SCALE FROM DRAWINGS -CONTRACTORS TO VERIFY ALL MEASUREMENTS & LOCATION OF SERVICES ON SITE PRIOR TO COMMENCING WORK, CONTACT DRAFTED.NZ FOR ANY CONTRADICTIONS OR ONSITE ANOMALIES -PLANS ARE TO BE CROSS REFERENCED & READ IN CONCURRENCE WITH PROJECT SPECIFICATIONS, CONSULTANT REPORTS & SPECIALIST DOCUMENTATION -ALL WORK TO BE CARRIED OUT IN ACCORDANCE WITH THE NEW ZEALAND BUILDING CODE, RELEVANT DISTRICT PLAN REQUIREMENTS & OR RESOURCE MANAGEMENT ACT -THE COPYRIGHT OF THIS DRAWING IS VESTED IN DRAFTED.NZ & IT MAY NOT BE REPRODUCED IN WHOLE OR PART OR USED FOR THE MANUFACTURE OF ANY ARTICLE WITHOUT THE EXPRESS PERMISSION OF THE COPYRIGHT HOLDERS.		PROJECT: NEW SINGLE STOREY DWELLING 58a KOTARE STREET, WAIKANAE		CLIENT: C & D TRUST		TITLE: ELEVATIONS			
	SCALE AT A3: 1:100		DATE: MAY 26		DRAWN: JS		CHECKED: JS		STATUS: BC			
	PROJECT NO: 3524		REVISION: --01		DRAWING NO: 07							

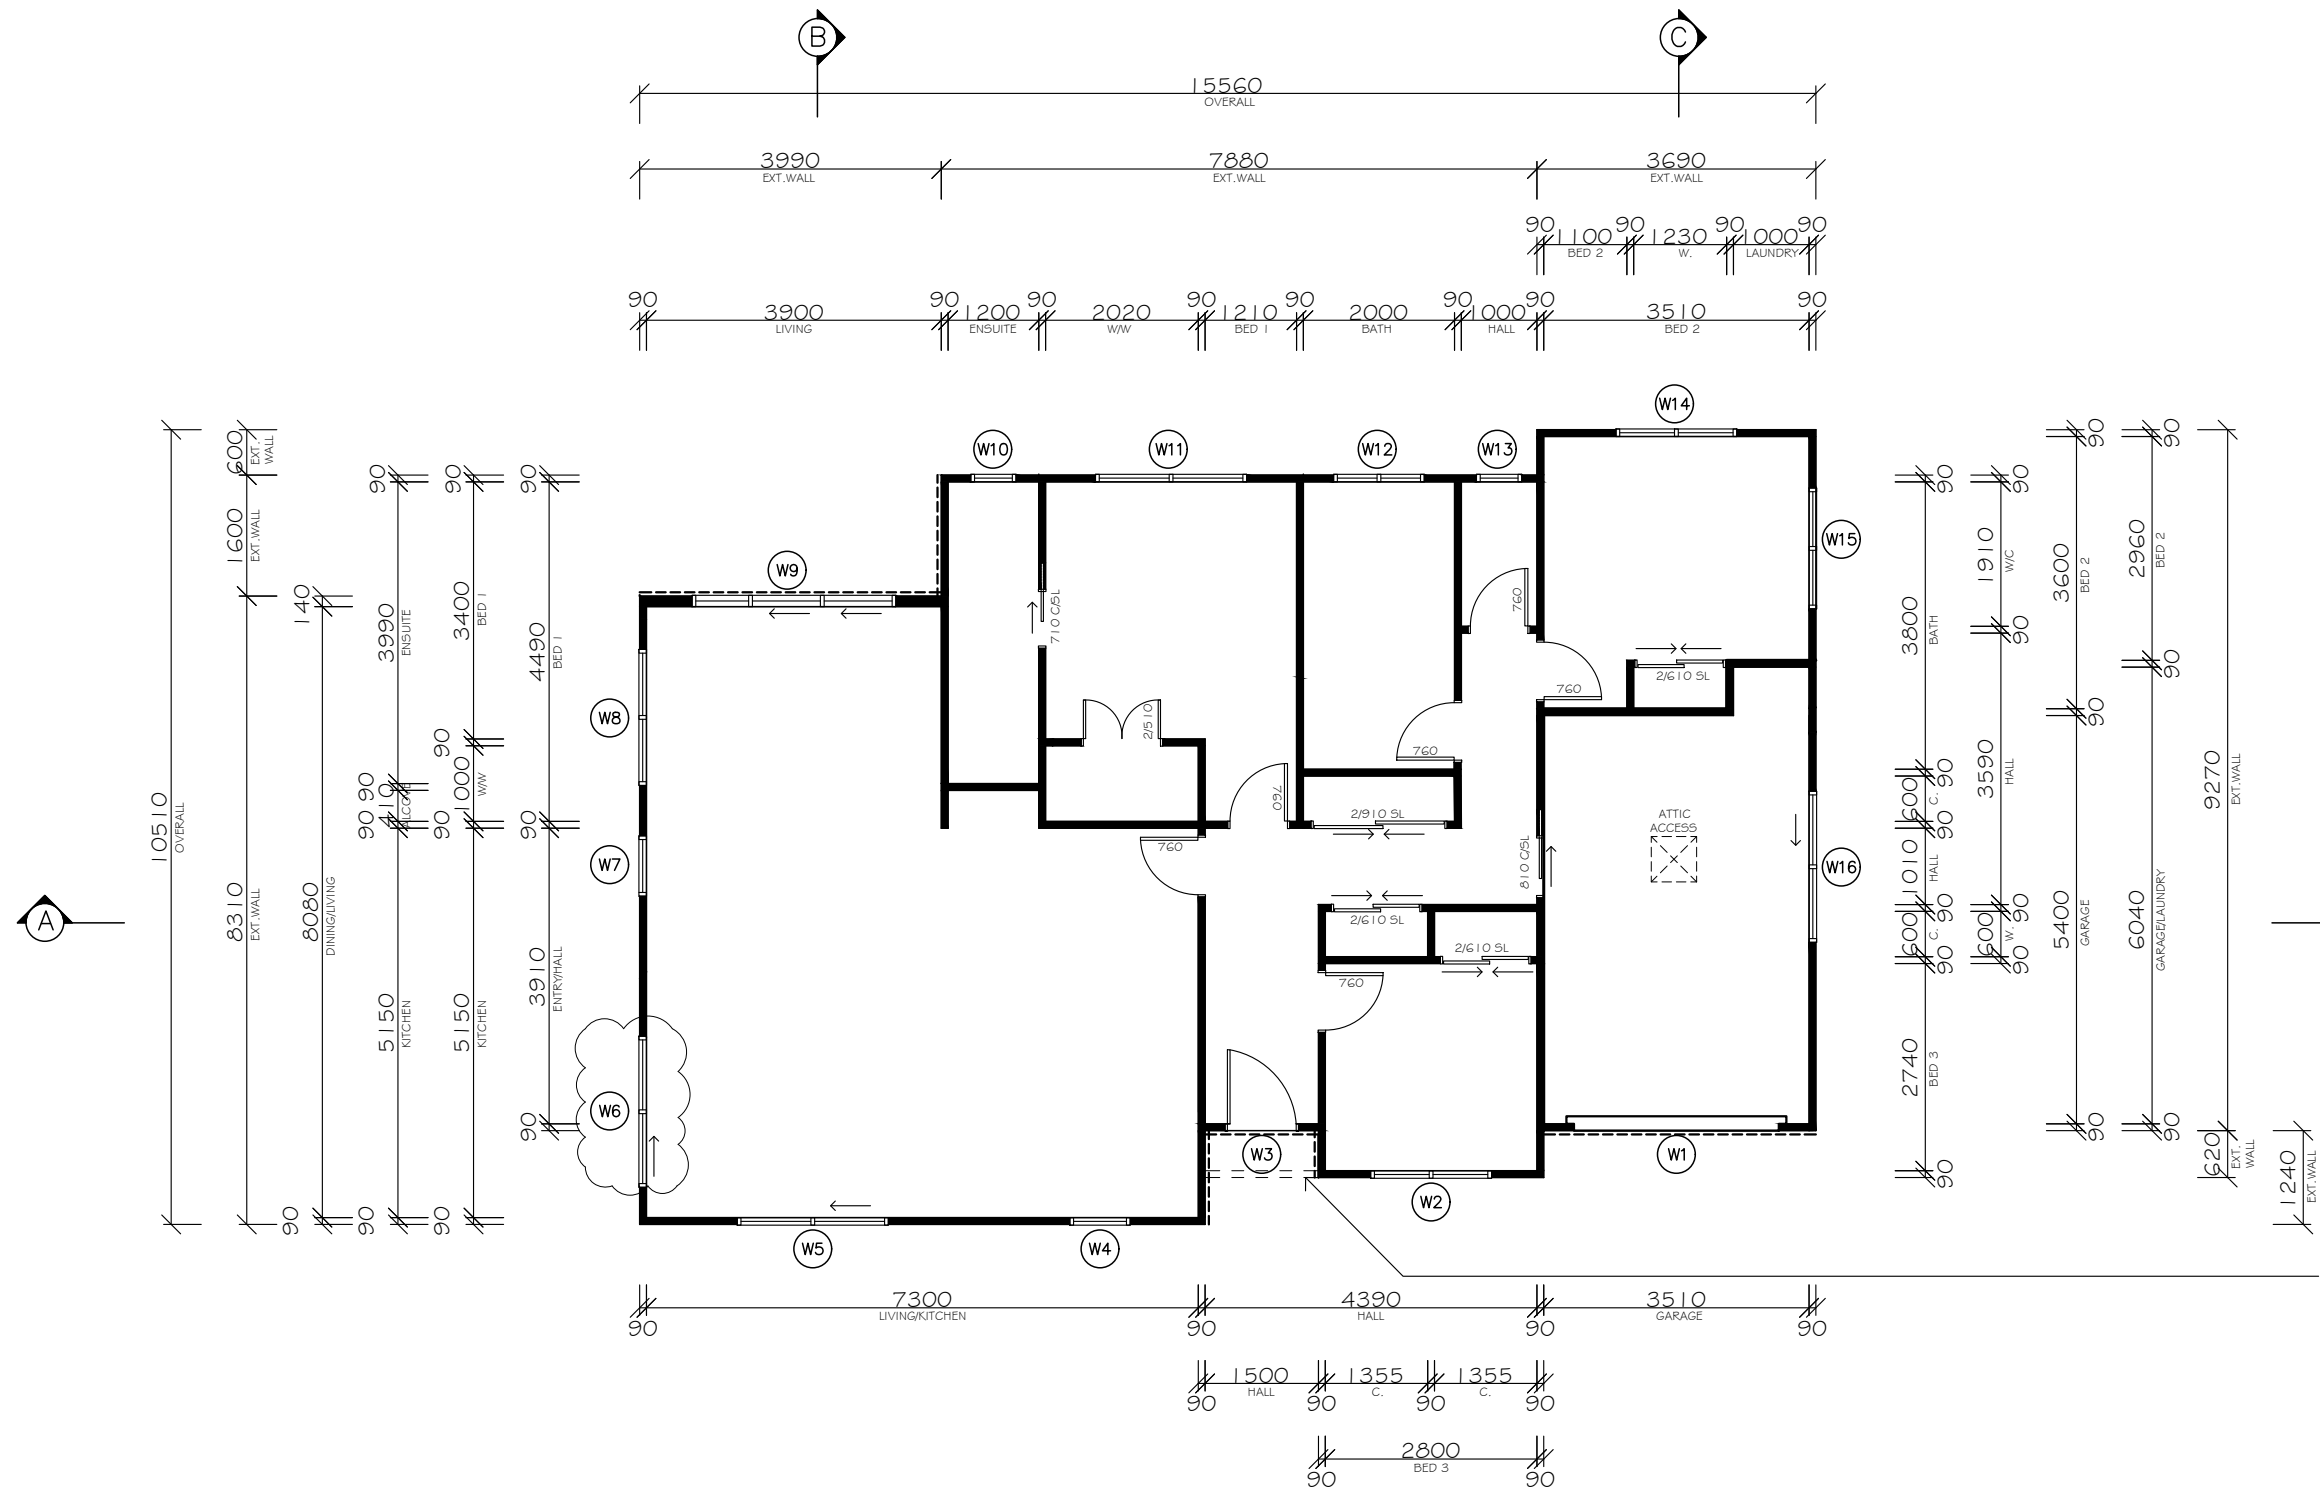

LINTEL BY PRE NAILER SET IN SOFFIT LINE FOR ADDITIONAL WIDTH SOFFIT, FIX WITH 6/100X4.0 HDG FLAT HEAD NAILS OF 4.7KN EQUIVALENT FIXING

FRAMING PLAN

SCALE 1:100

FLOOR AREA – 143m²

LEGEND:


- EXTERNAL WALL STUDS: 90x45 SG8 H1.2 STUDS @ 600 MAX CRS UP TO 2.420M FOR HIGH WIND ZONE, INTERNAL WALLS: 90x45 H1.2 STUDS @ 600 MAX CRS. NOGS: 90x45 H1.2 @ 600 CRS FOR STRATUM CLADDING & 800 CRS FOR W/B CLADDING
- W2 WINDOWS & DOORS

- 810 INTERNAL DOORS
- LOCATION OF FEATURE HORIZONTAL SPLAYCUT WEATHERBOARD CLADDING

FRAMING NOTES:

- ALL STRUCTURAL FRAMING (FRAMES, LINTELS, ROOF FRAMING ETC) TO BE SG8 KILN DRIED FRAMING TREATED TO SUIT LOCATION
- REFER ELEVATIONS FOR CLADDING SHEET SETOUT, SET OUT STUDS TO SUIT WITH BLOCKING/DOUBLE STUDS AS SPECIFIED IN CLADDING SPECIFICATION

	DRAFTED ARCHITECTURAL DESIGN	NOTES -DO NOT SCALE FROM DRAWINGS -CONTRACTORS TO VERIFY ALL MEASUREMENTS & LOCATION OF SERVICES ON SITE PRIOR TO COMMENCING WORK, CONTACT DRAFTED.NZ FOR ANY CONTRADICTIONS OR ONSITE ANOMALIES -PLANS ARE TO BE CROSS REFERENCED & READ IN CON-CURRENCE WITH PROJECT SPECIFICATIONS, CONSULTANT REPORTS & SPECIALIST DOCUMENTATION -ALL WORK TO BE CARRIED OUT IN ACCORDANCE WITH THE NEW ZEALAND BUILDING CODE, RELEVANT DISTRICT PLAN REQUIREMENTS & OR RESOURCE MANAGEMENT ACT -THE COPYRIGHT OF THIS DRAWING IS VESTED IN DRAFTED.NZ & IT MAY NOT BE REPRODUCED IN WHOLE OR PART OR USED FOR THE MANUFACTURE OF ANY ARTICLE WITHOUT THE EXPRESS PERMISSION OF THE COPYRIGHT HOLDERS.	PROJECT: NEW SINGLE STOREY DWELLING 58a KOTARE STREET, WAIKANAE	CLIENT: C & D TRUST	TITLE: FRAMING PLAN					
	11 TE HARAWIRA STREET OTAKI,NZ PHONE: 022 607 0234 EMAIL: drafted.nz@gmail.com www.drafted.nz				SCALE AT A3: 1:100		DATE: MAY 26	DRAWN: JS	CHECKED: JS	STATUS: BC
					PROJECT NO: 3524		REVISION: --01		DRAWING NO: 11	

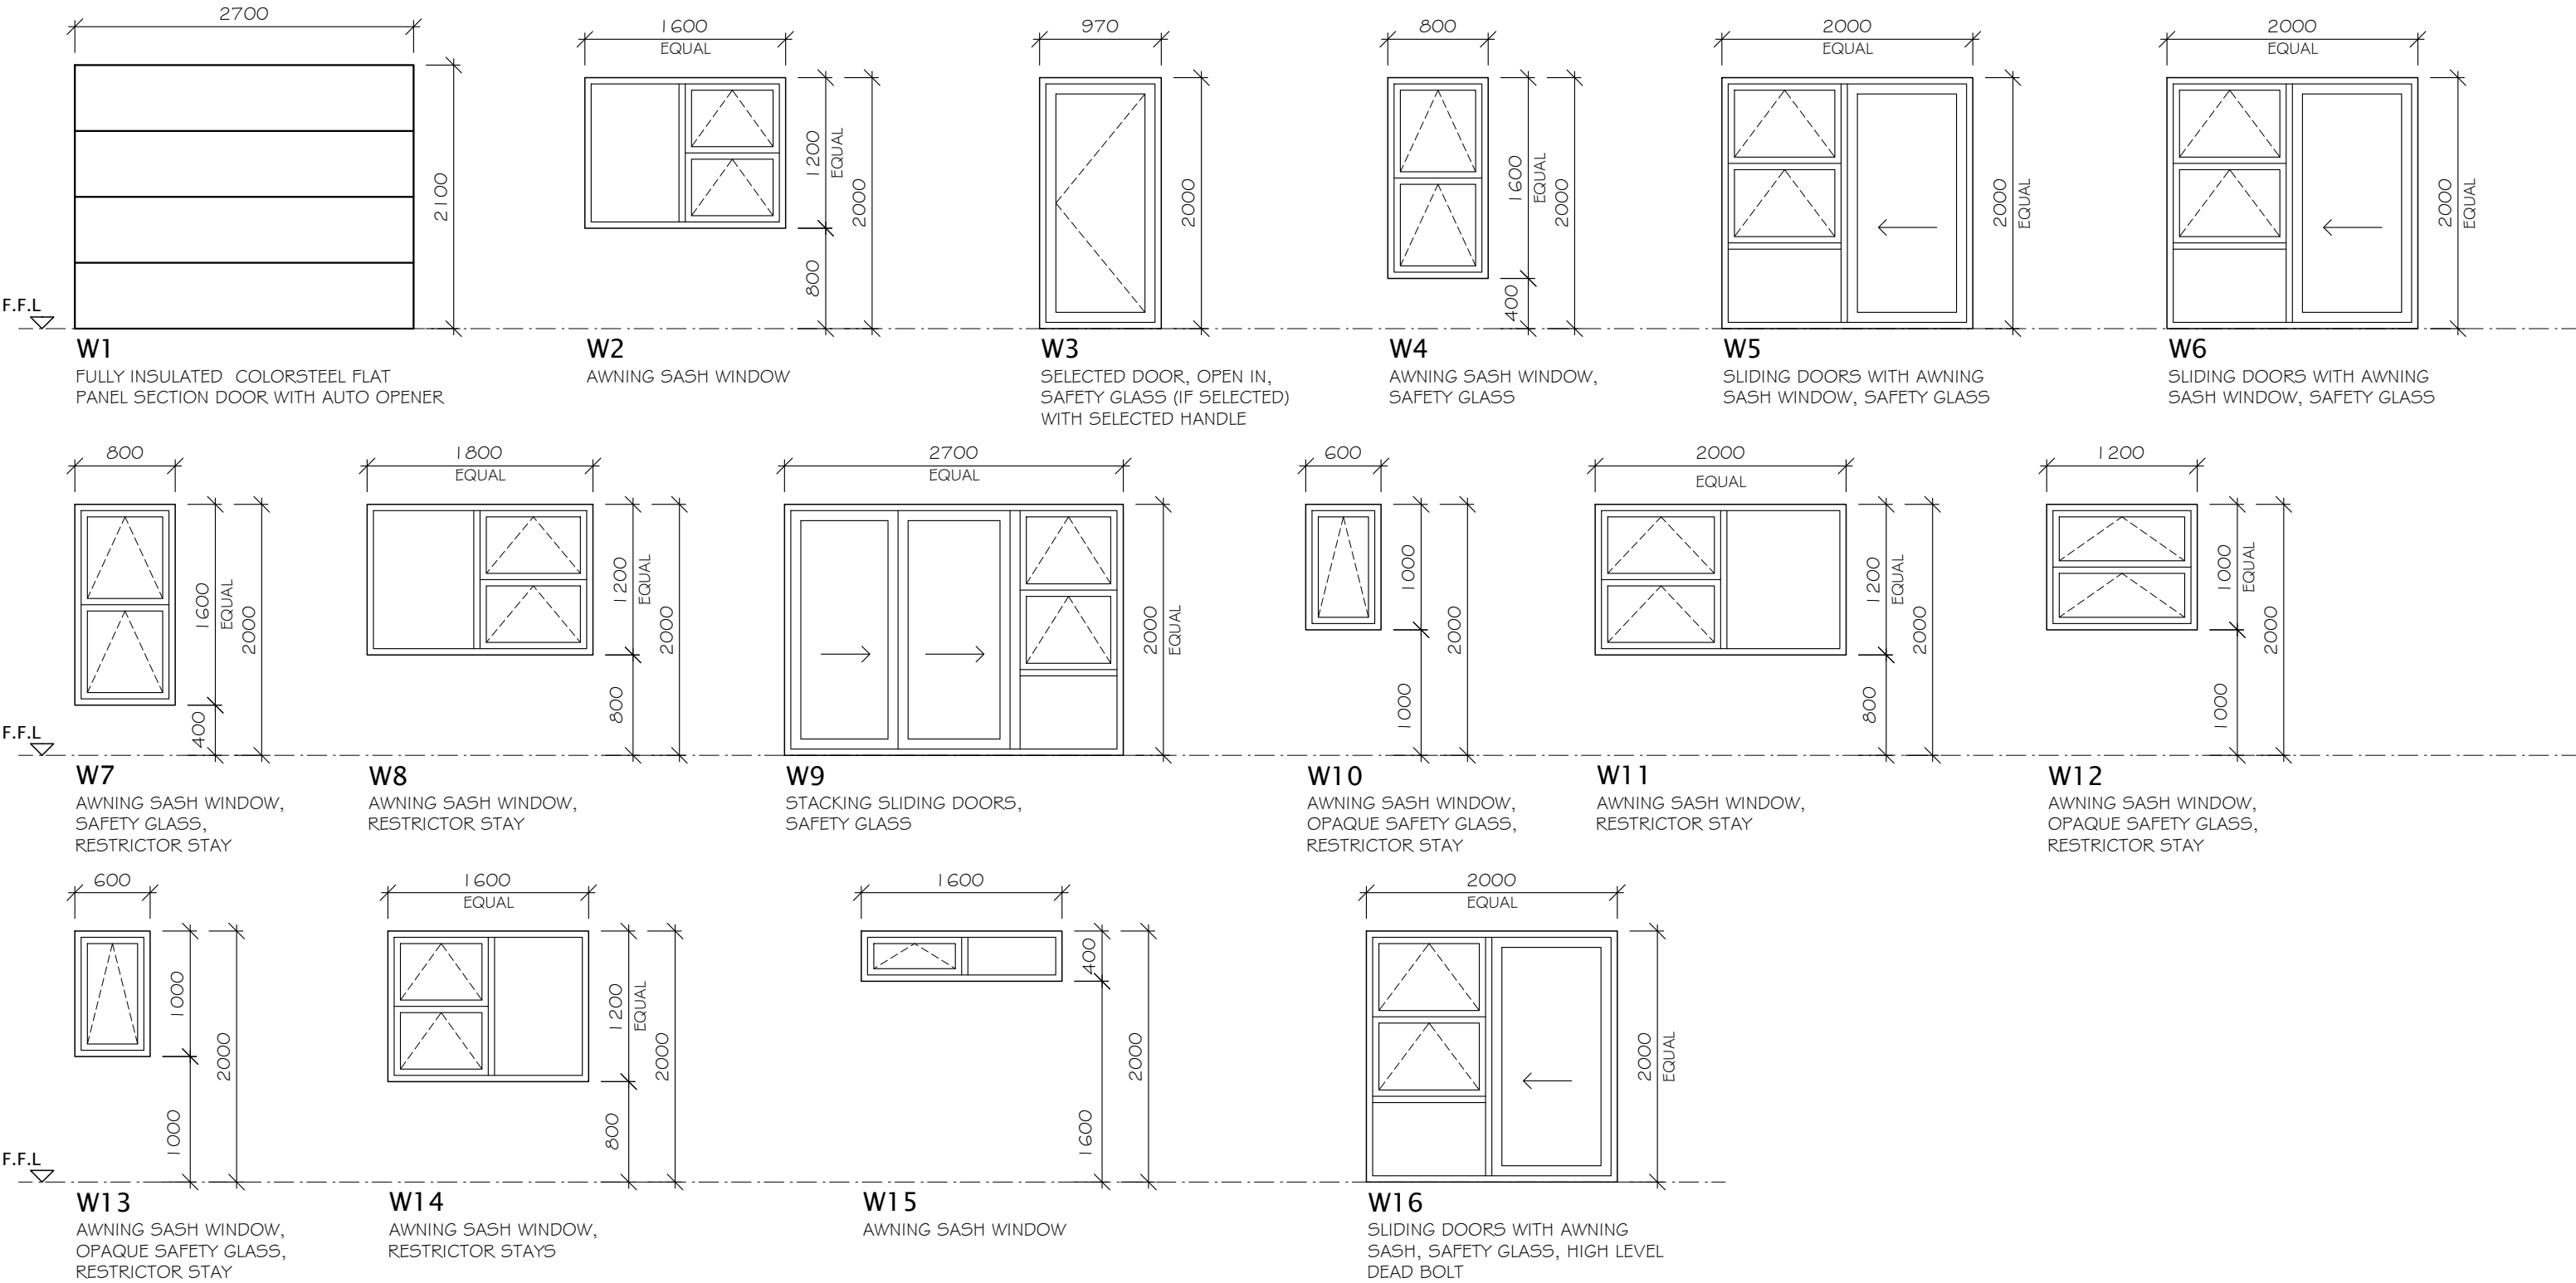

WINDOW SCHEDULE

SCALE 1:50

NOTES:

- WINDOWS SHOWN AS VIEWED FROM OUTSIDE, REFER FRAMING PLAN & ELEVATIONS FOR LOCATION
- ALL UNITS WITH POWDERCOAT FINISH
- ALL UNITS WITH COLOUR MATCHED HARDWARE, LARGE URBO D HANDLES TO ALL SLIDERS, ALL DOOR HANDLES INSTALLED @ 950mm TO CENTRELINE ABOVE F.F.L, ALL SASHES WITH DOUBLE TONGUE VENTED LATCHES (WHERE POSSIBLE)
- ALUMINIUM JOINER TO CHECK ALL OPENINGS SIZES & WINDOW CONFIGURATIONS ON SITE BEFORE MANUFACTURE

- ALL JOINERY TO COMPLY WITH NZS 4211
- ALL UNITS DOUBLE GLAZED FOR HIGH WIND ZONE, 1100PA DWP, SAFETY GLASS AS REQUIRED/NOMINATED, ALL GLAZING TO NZS4223
- ALL WINDOWS WITH MATCHING POWDERCOATED HEAD FLASHINGS & WRAP ALL OPENINGS WITH ALUBAND TAPE TO NZBC E2, REFER CLADDING SPECIFICATION & DETAILS FOR WEATHERPROOFING DETAILS
- ALL WINDOWS/DOORS TO HAVE WANZ SILL SUPPORT BRACKETS
- VERTICAL BGC STRATUM CLADDING & SELECTED RUSTICATED WEATHERBOARD CLADDING OVER 40X20 CAVITY BATTENS, REFER ELEVATIONS FOR CLADDING LOCATIONS



DRAFTED ARCHITECTURAL DESIGN

11 TE HARAWIRA STREET
OTAKI,NZ
PHONE: 022 607 0234
EMAIL: drafted.nz@gmail.com
www.drafted.nz


NOTES

-DO NOT SCALE FROM DRAWINGS
-CONTRACTORS TO VERIFY ALL MEASUREMENTS & LOCATION OF SERVICES ON SITE PRIOR TO COMMENCING WORK, CONTACT DRAFTED.NZ FOR ANY CONTRADICTIONS OR ONSITE ANOMALIES
-PLANS ARE TO BE CROSS REFERENCED & READ IN CONCURRENCE WITH PROJECT SPECIFICATIONS, CONSULTANT REPORTS & SPECIALIST DOCUMENTATION
-ALL WORK TO BE CARRIED OUT IN ACCORDANCE WITH THE NEW ZEALAND BUILDING CODE, RELEVANT DISTRICT PLAN REQUIREMENTS & OR RESOURCE MANAGEMENT ACT
-THE COPYRIGHT OF THIS DRAWING IS VESTED IN DRAFTED.NZ & IT MAY NOT BE REPRODUCED IN WHOLE OR PART OR USED FOR THE MANUFACTURE OF ANY ARTICLE WITHOUT THE EXPRESS PERMISSION OF THE COPYRIGHT HOLDERS.

PROJECT:
NEW SINGLE STOREY DWELLING
58a KOTARE STREET, WAIKANAE

CLIENT:
C & D TRUST

TITLE: WINDOW SCHEDULE				
SCALE AT A3: 1:50	DATE: MAY 26	DRAWN: JS	CHECKED: JS	STATUS: BC
PROJECT NO: 3524	REVISION: --01	DRAWING NO: 12		

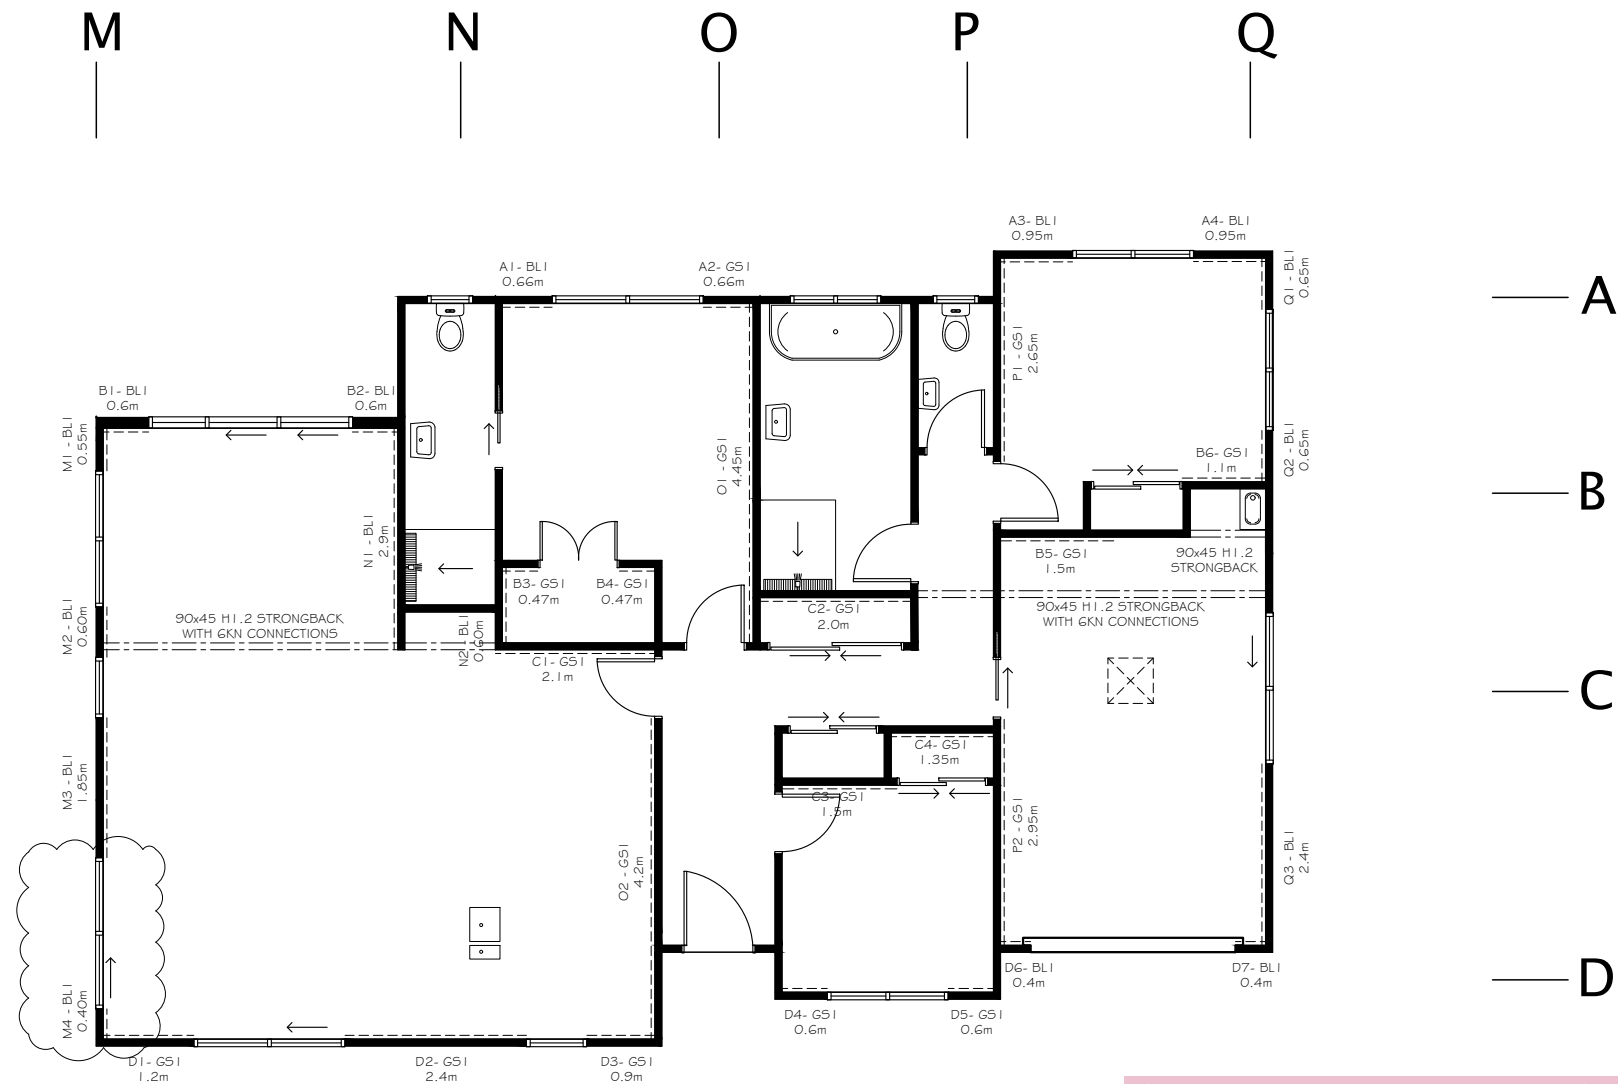


BRACING PLAN

SCALE 1:100

BRACING NOTES:

- ALL BRACING DESIGN FOR HIGH WIND ZONE
- ALL GIB BRACES FIXED TO MANUFACTURERS SPECIFICATIONS
- INSTALL GKN/I 2kN MITEK TOP PLATE FIXINGS TO ALL INTERNAL BRACES AT RIGHT ANGLES TO EXTERNAL WALLS, WHERE REQUIRED
- INSTALL STRONG BACK (TO EXTERIOR WALL) TO CONTINUE BRACING LINE WHERE SHOWN
- SUBFLOOR BRACING BY ENGINEER

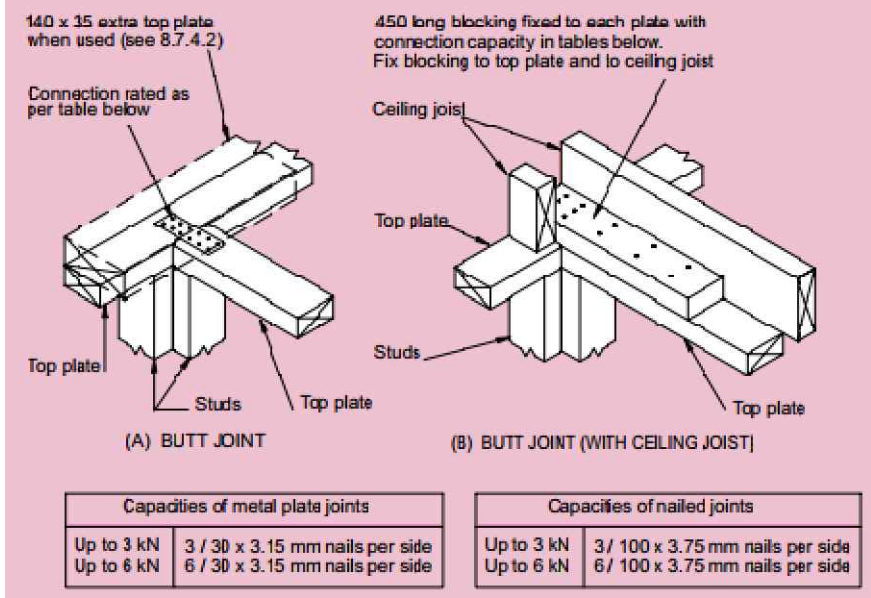



DRAFTED ARCHITECTURAL
DESIGN

11 TE HARAWIRA STREET
OTAKI,NZ
PHONE: 022 607 0234
EMAIL: drafted.nz@gmail.com
www.drafted.nz

NOTES

- DO NOT SCALE FROM DRAWINGS
- CONTRACTORS TO VERIFY ALL MEASUREMENTS & LOCATION OF SERVICES ON SITE PRIOR TO COMMENCING WORK. CONTACT DRAFTED.NZ FOR ANY CONTRADICTIONS OR ONSITE ANOMALIES
- PLANS ARE TO BE CROSS REFERENCED & READ IN CONCORDANCE WITH PROJECT SPECIFICATIONS, CONSULTANT REPORTS & SPECIALIST DOCUMENTATION
- ALL WORK TO BE CARRIED OUT IN ACCORDANCE WITH THE NEW ZEALAND BUILDING CODE, RELEVANT DISTRICT PLAN REQUIREMENTS & OR RESOURCE MANAGEMENT ACT
- THE COPYRIGHT OF THIS DRAWING IS VESTED IN DRAFTED.NZ & IT MAY NOT BE REPRODUCED IN WHOLE OR PART OR USED FOR THE MANUFACTURE OF ANY ARTICLE WITHOUT THE EXPRESS PERMISSION OF THE COPYRIGHT HOLDERS.


PROJECT:
NEW SINGLE STOREY DWELLING
58a KOTARE STREET, WAIKANAE

CLIENT:
C & D TRUST

TITLE:
BRACING PLAN

SCALE AT A3: 1:100	DATE: MAY 26	DRAWN: JS	CHECKED: JS	STATUS: BC
PROJECT NO: 3524	REVISION: --01	DRAWING NO: 13		

Lighting		
	Single Gang Switch	9 EA
	Double Gang Switch	3 EA
	Triple Gang Switch	3 EA
	2 Way Switching	2 EA
	Intermediate Switching	3 EA
	Halcyon 8W 3-4K 90mm Downlight White	27 EA
	LED Batten Light (60W 4K 1500mm Barry)	2 EA
	Exterior Wall Light Connection (Pick Fitting)	4 EA
	Vanity Light Connection (Pick Fitting)	2 EA
	Pendant Light Connection (Pick Fitting)	3 EA
	Exterior Twin Spot Sensor	2 EA
	In-line Fan 150mm 6m	2 EA
	Cavius Interconnect 10yr Smoke Alarm	5 EA

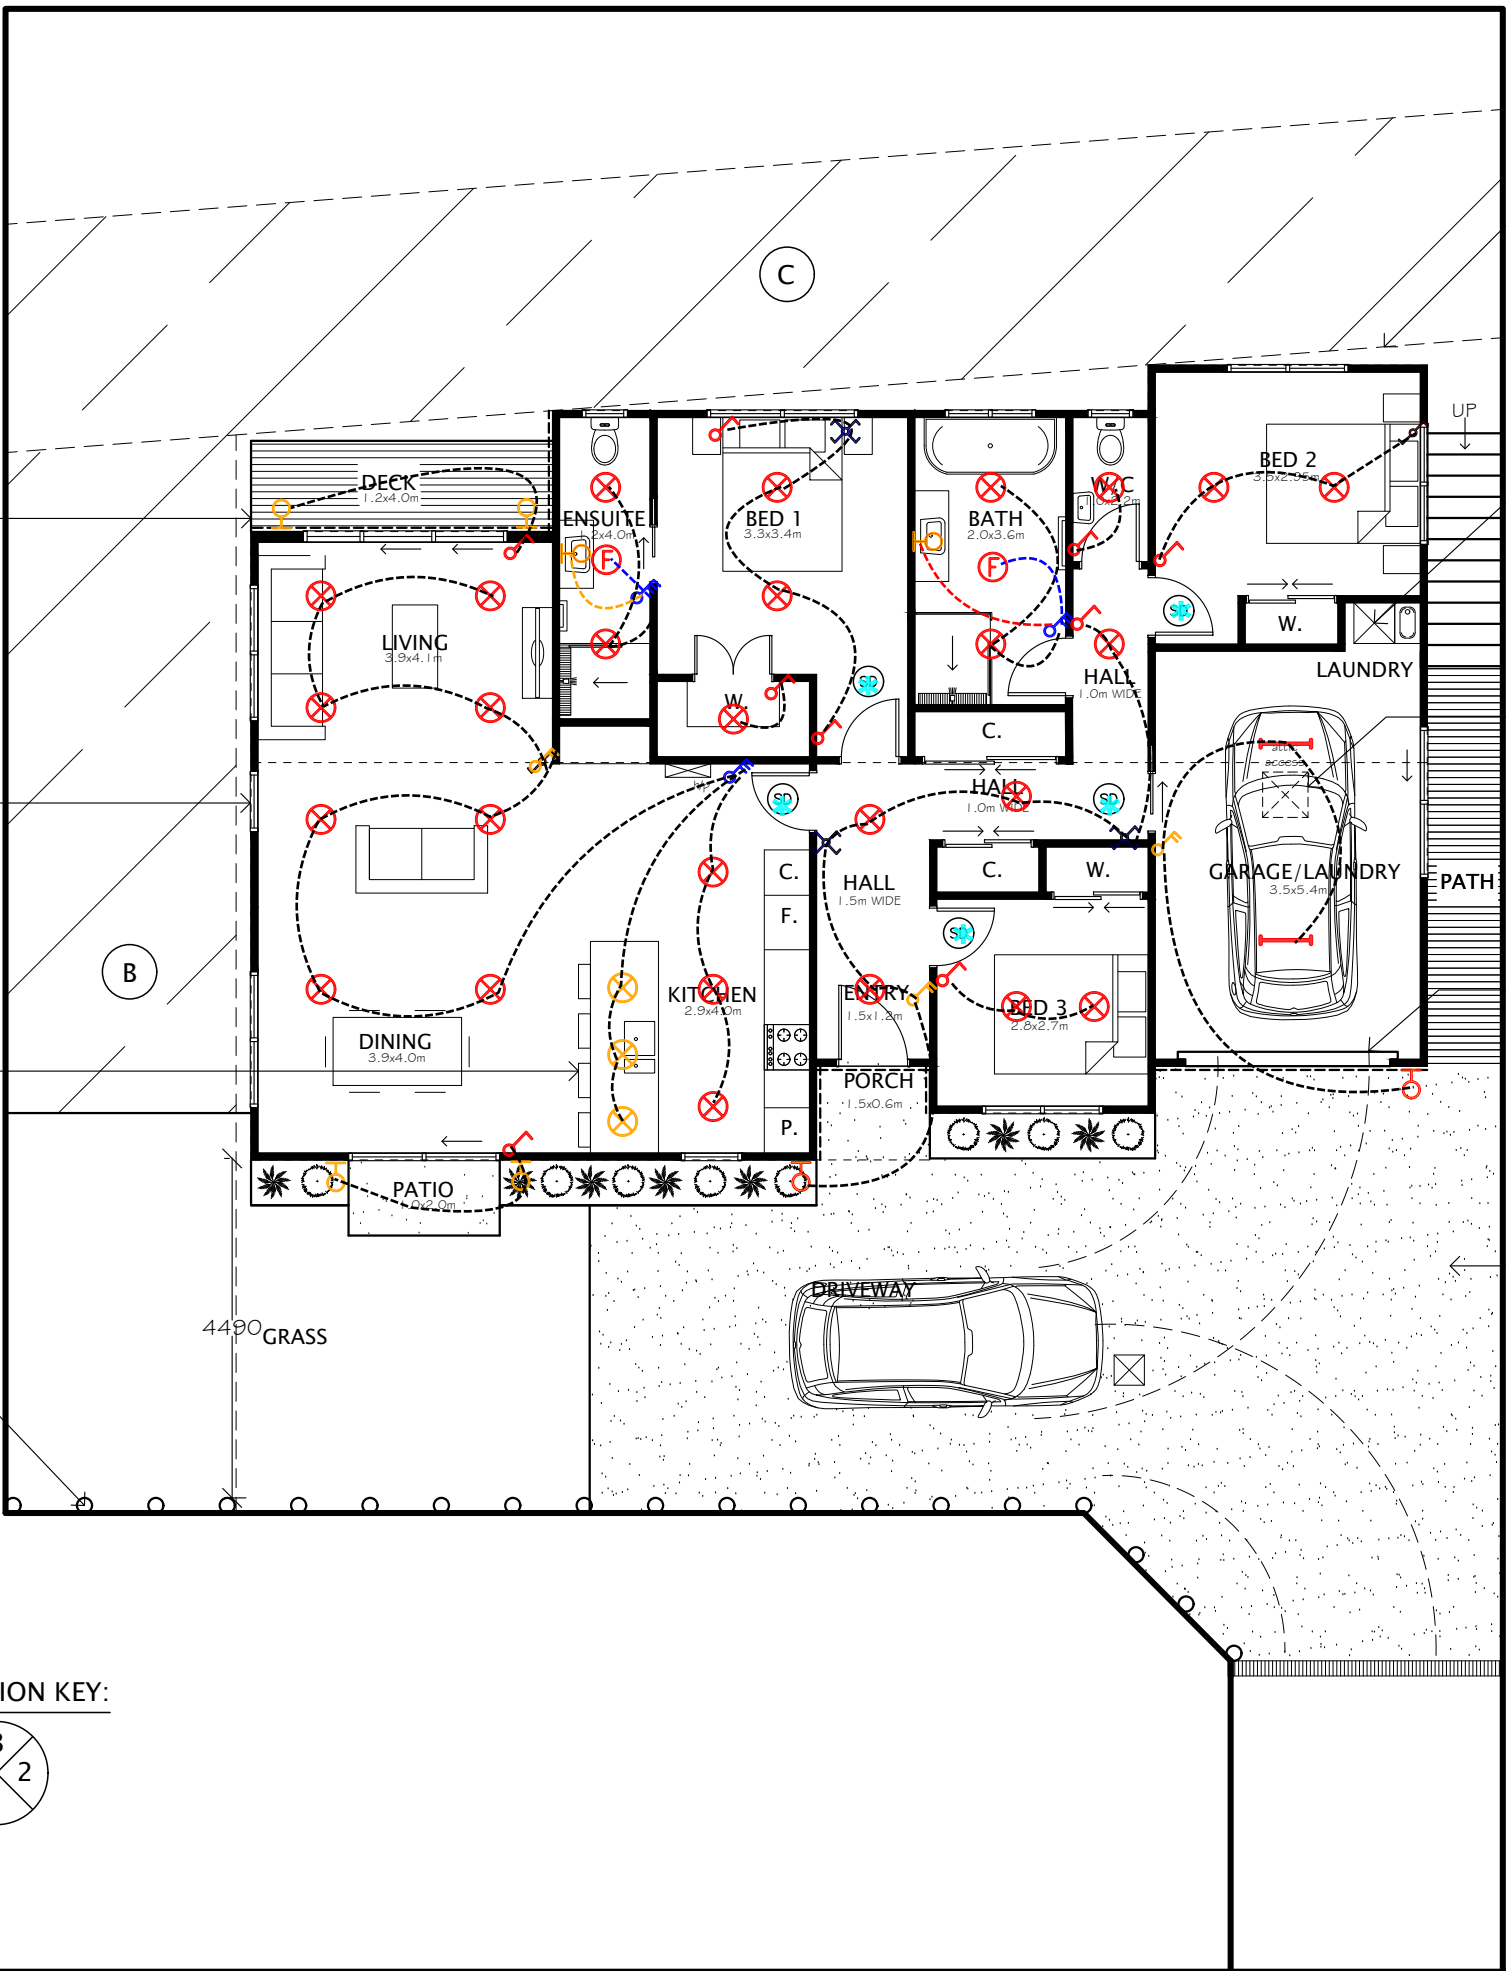


INDICATIVE LOCATION OF ATTIC ACCESS

SECTIONAL GARAGE DOOR WITH AUTO OPENER

PROPOSED FLOOR PLAN
SCALE 1:100
TOTAL FLOOR AREA: 143M2
LEGEND:

- TIMBER FRAMING
- LOCATION OF FEATURE
HORIZONTAL DOUBLE SPLAYCUT
WEATHERBOARD CLADDING
- SMOKE DETECTORS INSTALLED
WHERE SHOWN
- EXTENT PAVED/CONCRETE AREAS

 ELEVATION KEY:





DRAFTED ARCHITECTURAL DESIGN
11 TE HARAWIRA STREET
OTAKI, NZ
PHONE: 022 607 0234
EMAIL: drafted.nz@gmail.com
www.drafted.nz

NOTES
-DO NOT SCALE FROM DRAWINGS
-CONTRACTORS TO VERIFY ALL MEASUREMENTS & LOCATION OF SERVICES ON SITE PRIOR TO COMMENCING WORK. CONTACT DRAFTED.NZ FOR ANY CONTRADICTIONS OR ONSITE ANOMALIES
-PLANS ARE TO BE CROSS REFERENCED & READ IN CONCURRENCE WITH PROJECT SPECIFICATIONS, CONSULTANT REPORTS & SPECIALIST DOCUMENTATION
-ALL WORK TO BE CARRIED OUT IN ACCORDANCE WITH THE NEW ZEALAND BUILDING CODE, RELEVANT DISTRICT PLAN REQUIREMENTS & OR RESOURCE MANAGEMENT ACT
-THE COPYRIGHT OF THIS DRAWING IS VESTED IN DRAFTED.NZ & IT MAY NOT BE REPRODUCED IN WHOLE OR PART OR USED FOR THE MANUFACTURE OF ANY ARTICLE WITHOUT THE EXPRESS PERMISSION OF THE COPYRIGHT HOLDERS.


PROJECT:
NEW SINGLE STOREY DWELLING
KOTARE STREET, WAIKANAE

CLIENT:
C & D TRUST

TITLE:
FLOOR PLAN

SCALE AT A3: 1:100	DATE: JULY 25	DRAWN: JS	CHECKED: JS	STATUS: BC
PROJECT NO: 3524	REVISION: ----	DRAWING NO: 05		

Power		
	Vynco 34way Combo Board (Single Phase)	1 EA
	Earth Electrode	1 EA
	24port Data Board	1 EA
	Single Horizontal	1 EA
	Double Horizontal	24 EA
	Double outdoor outlet	2 EA
	Air-conditioner Circuit	1 EA
	Wall Oven Connection	1 EA
	Standard Hob Connection (32a)	1 EA
	Hot Water Cylinder connection	1 EA
	Rangehood Soffit Exit (Ducting and grill 6m)	1 EA
	Heated Towel Rail Connection	2 EA
	Data Outlet (Double)	1 EA

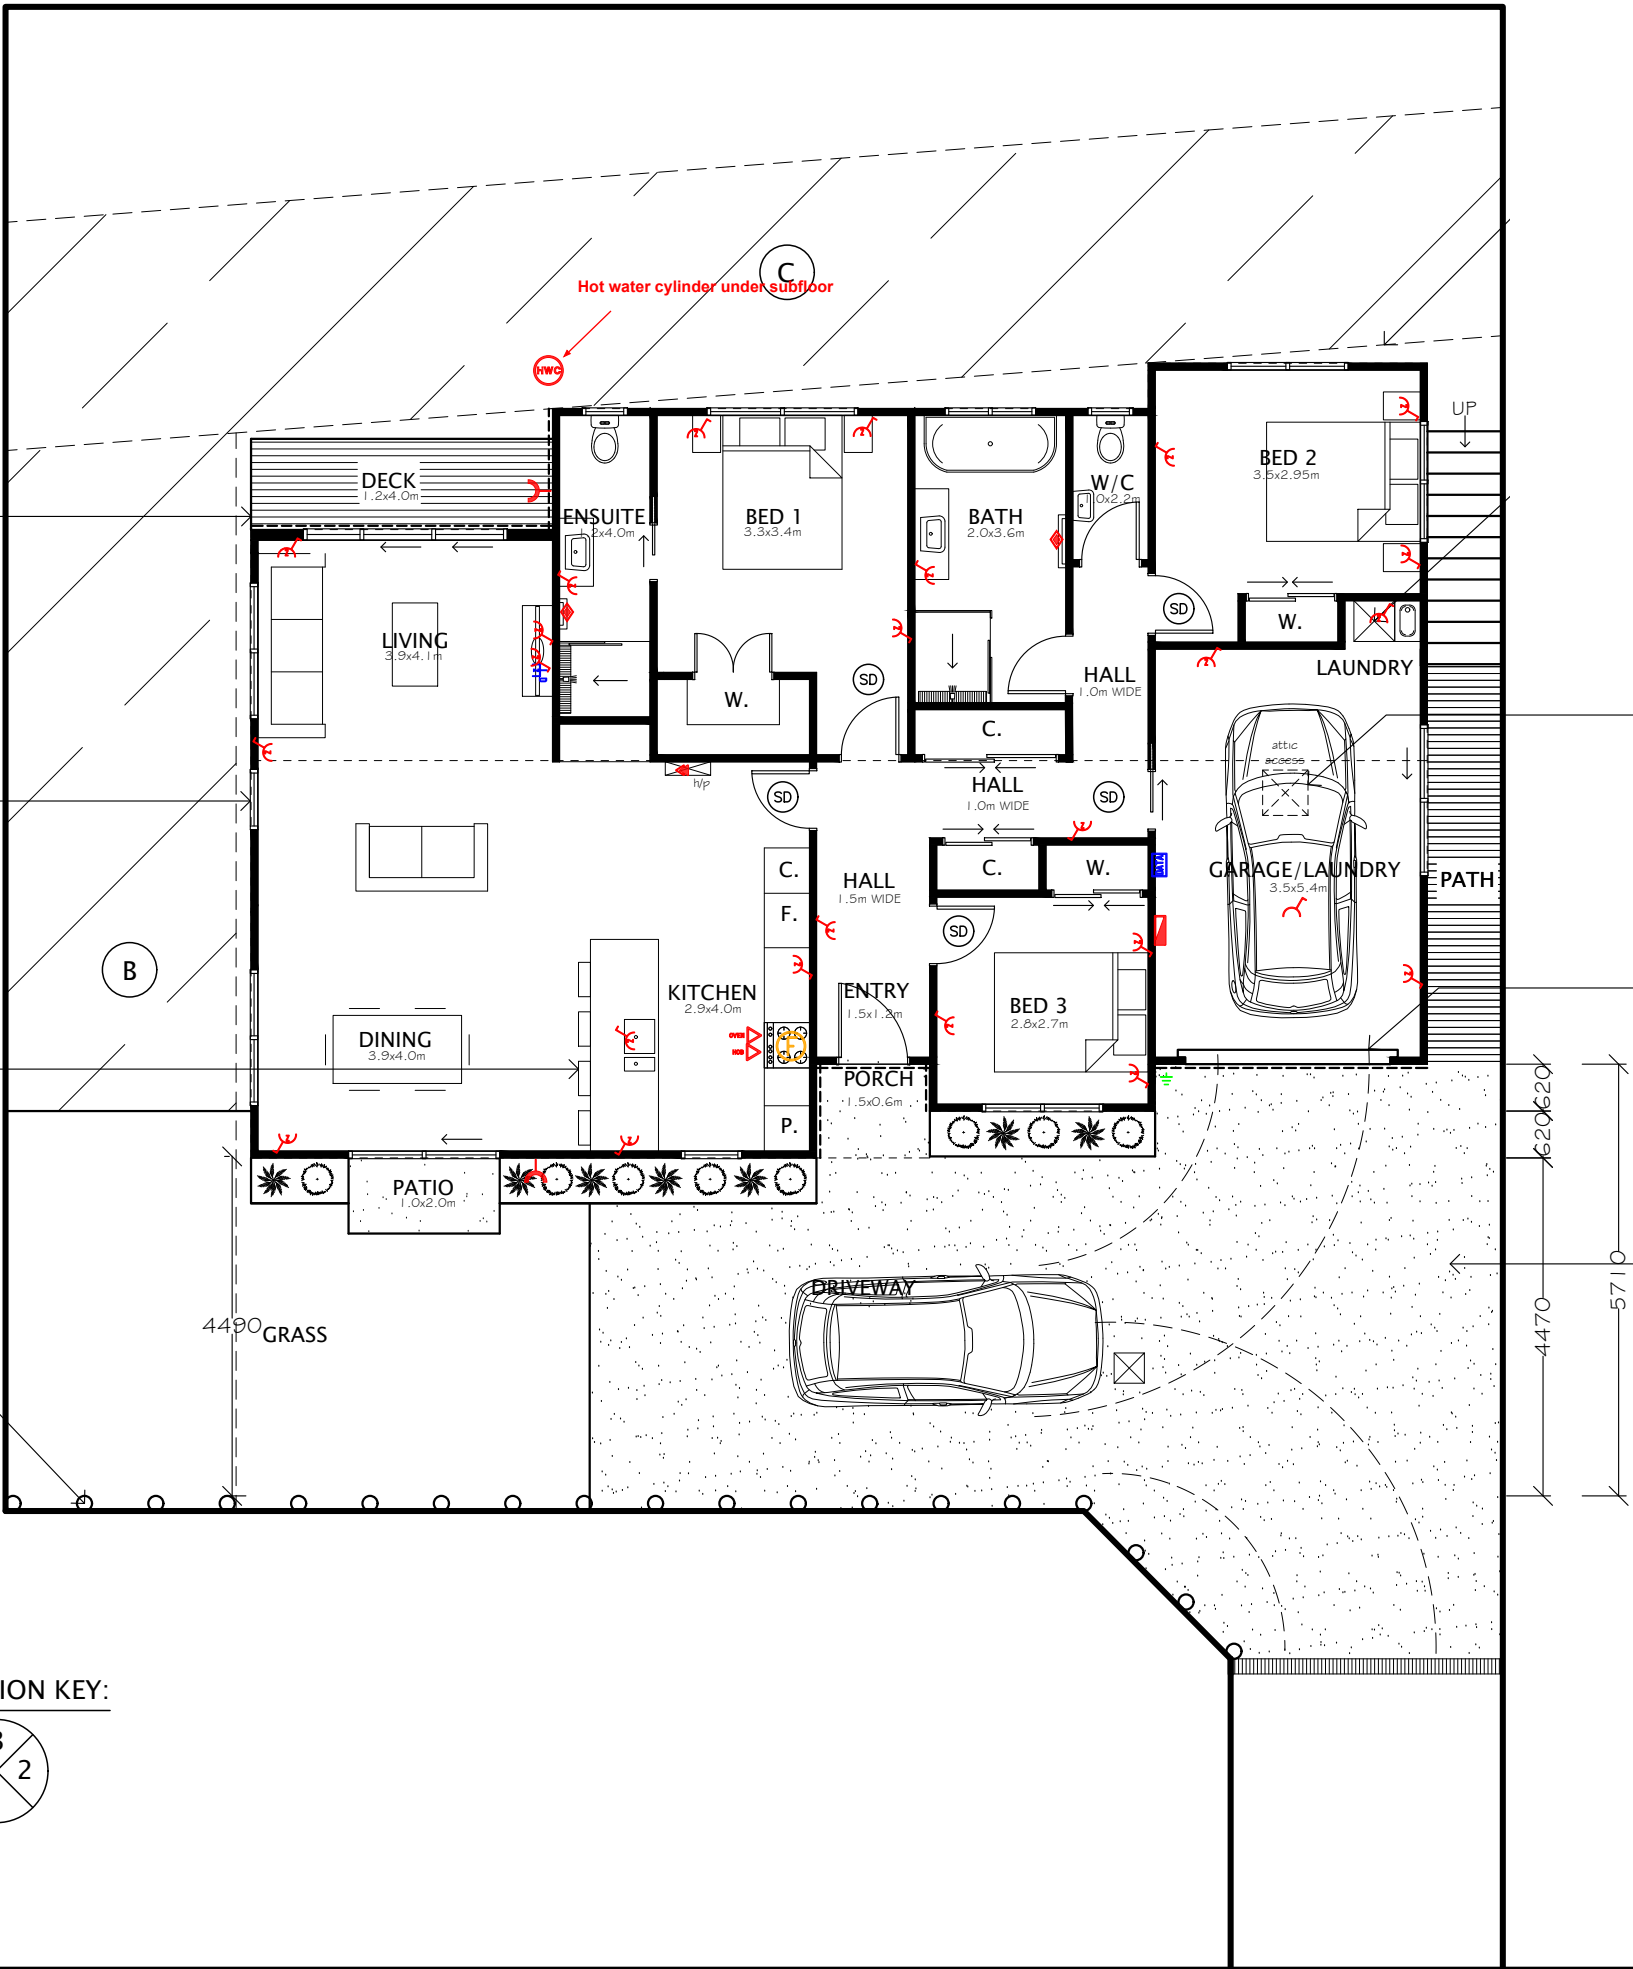

PROPOSED FLOOR PLAN
SCALE 1:100
TOTAL FLOOR AREA: 143M2
LEGEND:

- TIMBER FRAMING
- LOCATION OF FEATURE
HORIZONTAL DOUBLE SPLAYCUT
WEATHERBOARD CLADDING
- SMOKE DETECTORS INSTALLED
WHERE SHOWN
- EXTENT PAVED/CONCRETE AREAS

ELEVATION KEY:

